




1 W-CLIP DETAIL
SCALE: 1" = 1"

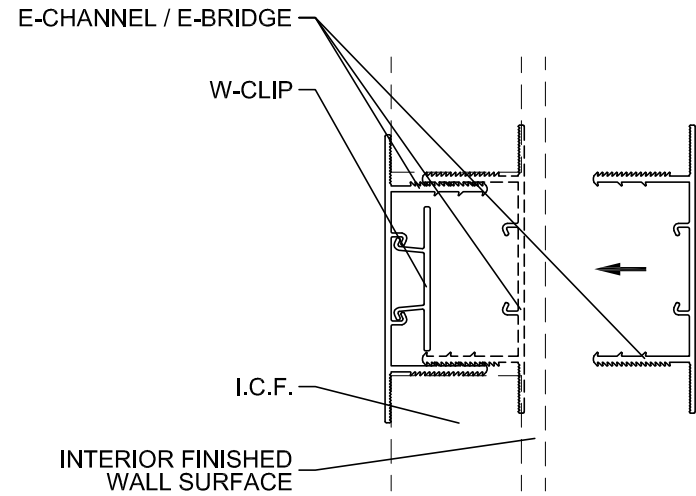

3 TYPICAL E-CONNECT ASSEMBLY DETAIL
SCALE: 1/4" = 1"

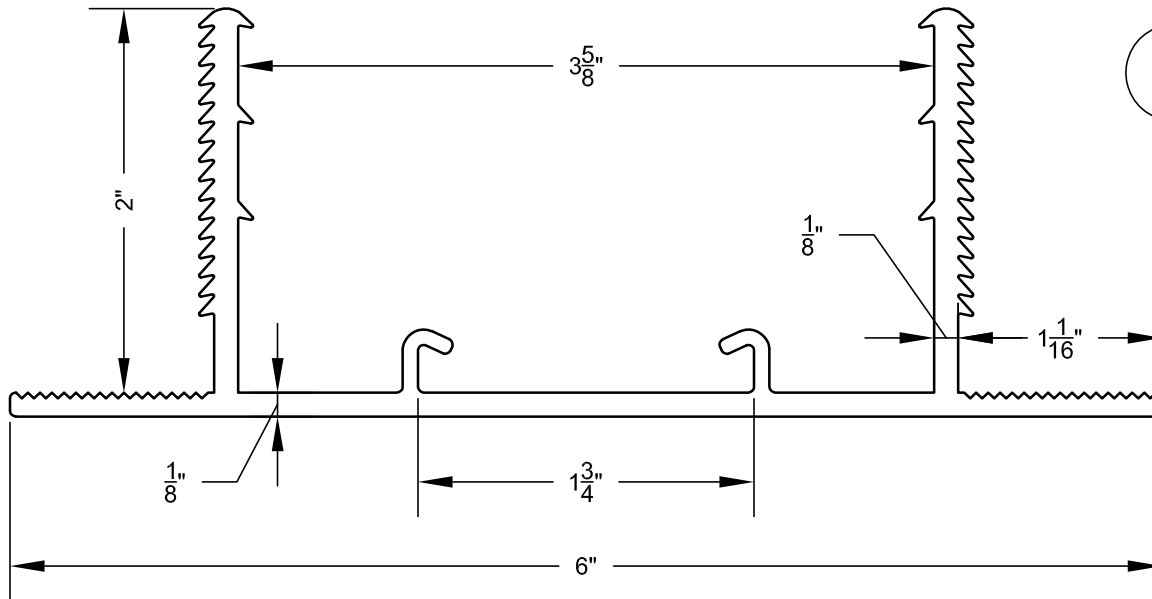

2 E-CHANNEL / E-BRIDGE DETAIL
SCALE: 1" = 1"

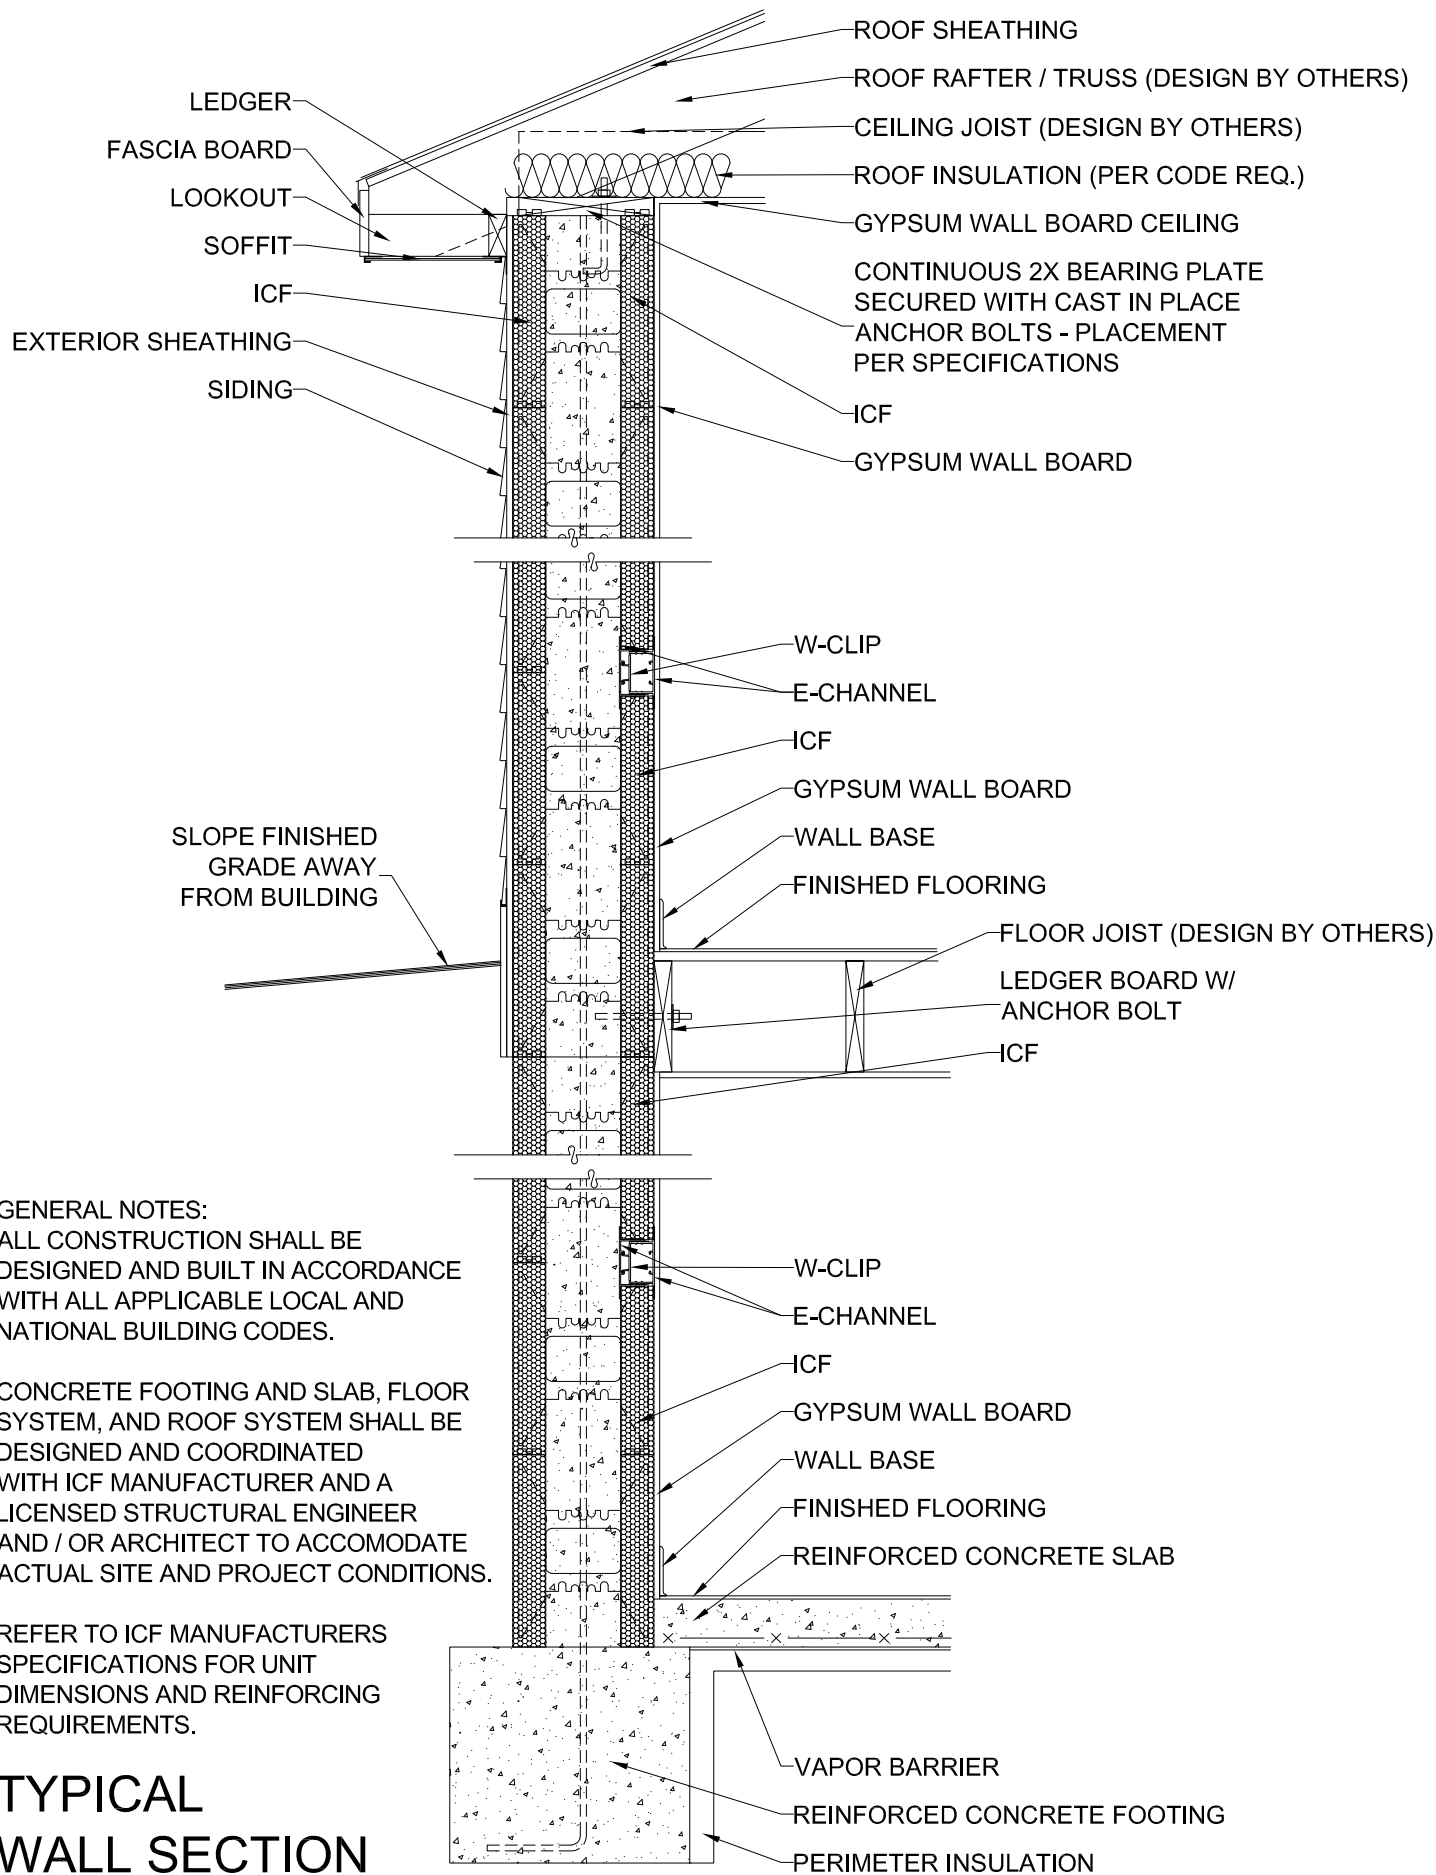

GENERAL NOTES:
 ALL CONSTRUCTION SHALL BE DESIGNED AND BUILT IN ACCORDANCE WITH ALL APPLICABLE LOCAL AND NATIONAL BUILDING CODES.

CONCRETE FOOTING AND SLAB, FLOOR SYSTEM, AND ROOF SYSTEM SHALL BE DESIGNED AND COORDINATED WITH ICF MANUFACTURER AND A LICENSED STRUCTURAL ENGINEER AND / OR ARCHITECT TO ACCOMMODATE ACTUAL SITE AND PROJECT CONDITIONS.

REFER TO ICF MANUFACTURERS SPECIFICATIONS FOR UNIT DIMENSIONS AND REINFORCING REQUIREMENTS.

TYPICAL WALL SECTION

SCALE: 3/4" = 1'-0"